



2nd FLOOR PLAN  
SCALE: 3/16" = 1'  
1015 SQ. FT.

<p>PREPARED FOR:</p> <p>RACHEL KIMEL 36 HILLCREST DRIVE TORONTO, ON M6G 2E6</p>	<p>ADDRESS:</p> <p>36 HILLCREST DRIVE TORONTO</p>	<p>LOCATION PLAN:</p>	<p>DATE:</p> <p>JANUARY 23, 2014</p>	<p>SCALE:</p> <p>3/16" = 1'</p>
			<p>DISCLAIMER:</p> <p>Note: These floor plans are to be used for preliminary planning purposes only. No warranty is made or implied as to the accuracy of dimensions. All dimensions must be site verified prior to construction. All quantities are estimates. Wall thicknesses or dimensions may be subject to change. Plans cannot be used for construction purposes.</p>	

- |  |                   |  |                       |
|--|-------------------|--|-----------------------|
|  | FLOURESCENT LIGHT |  | TV CABLE              |
|  | CEILING HVAC      |  | SMOKE DETECTOR        |
|  | CEILING LIGHT     |  | SHOWER LIGHT          |
|  | CEILING FAN       |  | RECESSED LIGHT        |
|  | CEILING SPEAKER   |  | THERMOSTAT            |
|  | WALL HVAC         |  | CEILING MOUNTED LIGHT |
|  | FLOOR HVAC        |  | NETWORK               |
|  | OUTLET            |  | CHANDELIER            |
|  | SWITCH            |  | WALL MOUNTED LIGHT    |

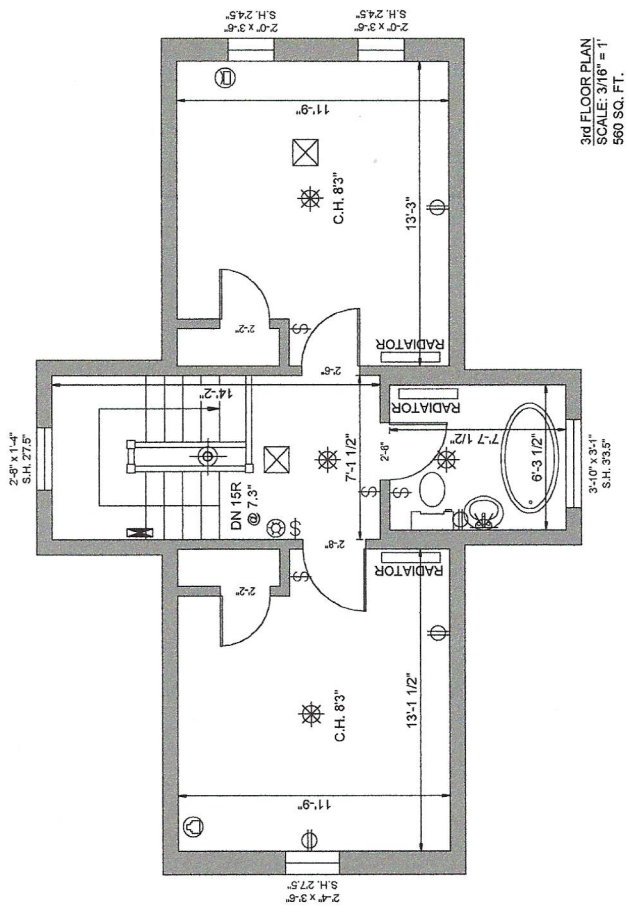

 
3rd FLOOR PLAN  
SCALE: 3/16" = 1'  
560 SQ. FT.



PLANIT MEASURING @  
1-800-333-5136  
MISSISSAUGA, ONTARIO  
www.planitmeasuring.com  
info@planitmeasuring.com

© 2014 PLANIT MEASURING


DATE: JANUARY 23, 2014  
SCALE: 3/16" = 1'  
DISCLAIMER:  
Note: These floor plans are to be used for preliminary planning purposes only. No warranty is made or implied as to the accuracy of the information shown. All dimensions are to be verified. Plans are not to be used for quantity estimates. Wall thickness or composition has not been determined. Plans cannot be used for construction purposes.

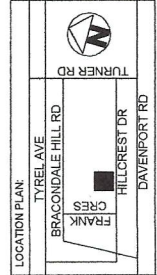

ADDRESS: 36 HILLCREST DRIVE TORONTO  
DRAWING TITLE: 3RD FLOOR PLAN

PREPARED FOR: RACHEL KIMEL  
36 HILLCREST DRIVE  
TORONTO, ON M6G 2E6

	FLUORESCENT LIGHT		TV CABLE
	CEILING HVAC		SMOKE DETECTOR
	EXHAUST FAN		SHOWER LIGHT
	CEILING SPEAKER		RECESSED LIGHT
	WALL HVAC		WALL MOUNTED LIGHT
	FLOOR HVAC		CHANDELIER
	OUTLET		NETWORK
	SWITCH		THERMOSTAT

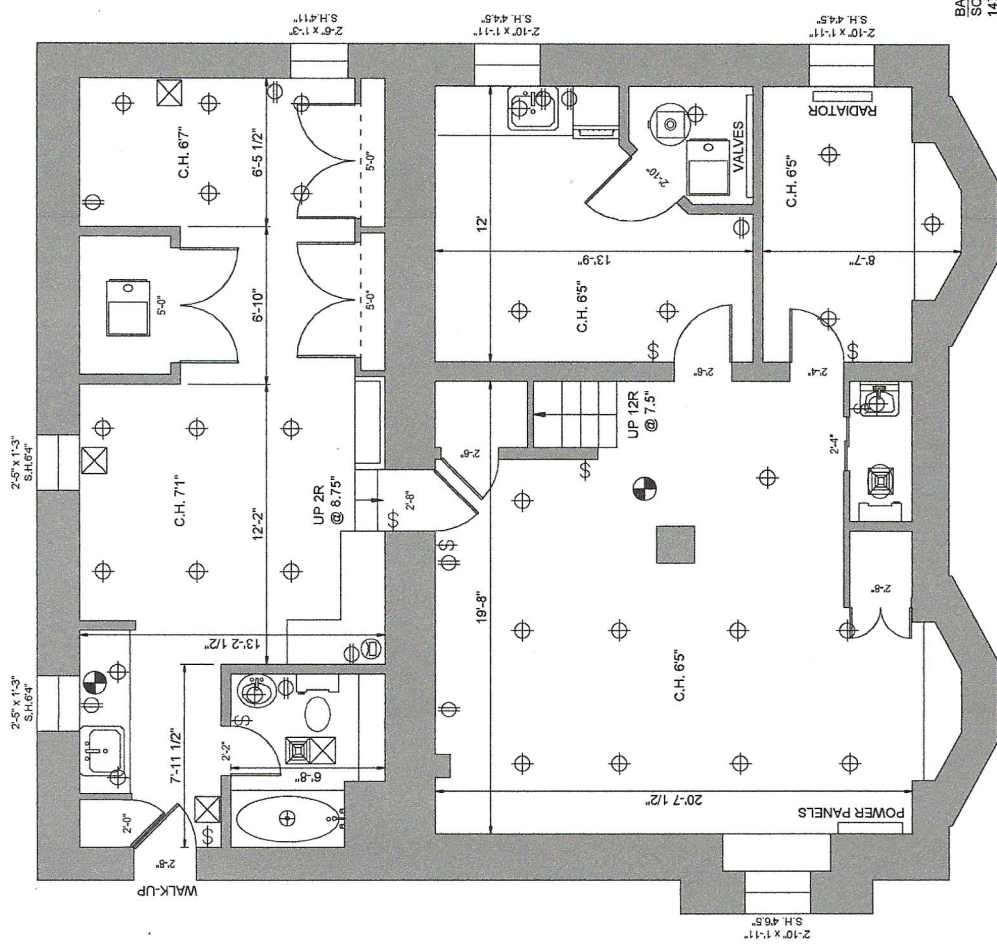

BASEMENT PLAN  
SCALE: 3/16" = 1'  
1475 SQ. FT.

PREPARED FOR:  
RACHEL KIMEL  
36 HILLCREST DRIVE  
TORONTO, ON M6G 2E6

ADDRESS:  
36 HILLCREST DRIVE  
TORONTO

DRAWING TITLE:  
BASEMENT PLAN

LOCATION PLAN:  
TYRE LAVE  
BRACONDALE HILL RD  
FRANK  
HILLCREST DR  
DAVENPORT RD  
TURNER RD

DATE: JANUARY 23, 2014  
SCALE: 3/16" = 1'

DISCLAIMER:  
Note: These floor plans are to be used for preliminary purposes only. They are not to be used for construction or to the accuracy of dimensions. All dimensions must be site verified. Plans are not to be used for quantity estimates. Wall thickness or composition has not been determined. Plans cannot be used for construction purposes.

PLANT MEASURING ©  
1-800-333-5138  
MISSISSAUGA, ONTARIO  
info@plantmeasuring.com

	FLOUSCENT LIGHT		TV CABLE
	CEILING HVAC		SMOKE DETECTOR
	EXHAUST FAN		SHOWER LIGHT
	CEILING SPEAKER		RECESSED LIGHT
	WALL HVAC		THERMOSTAT
	FLOOR HVAC		CEILING MOUNTED LIGHT
	OUTLET		NETWORK
	SWITCH		CHANDELIER
	WALL MOUNTED LIGHT		HANDEILER